


**SINGLE LINE DIAGRAM OF 33/11KV KILOKARI GRID SUB STN.**

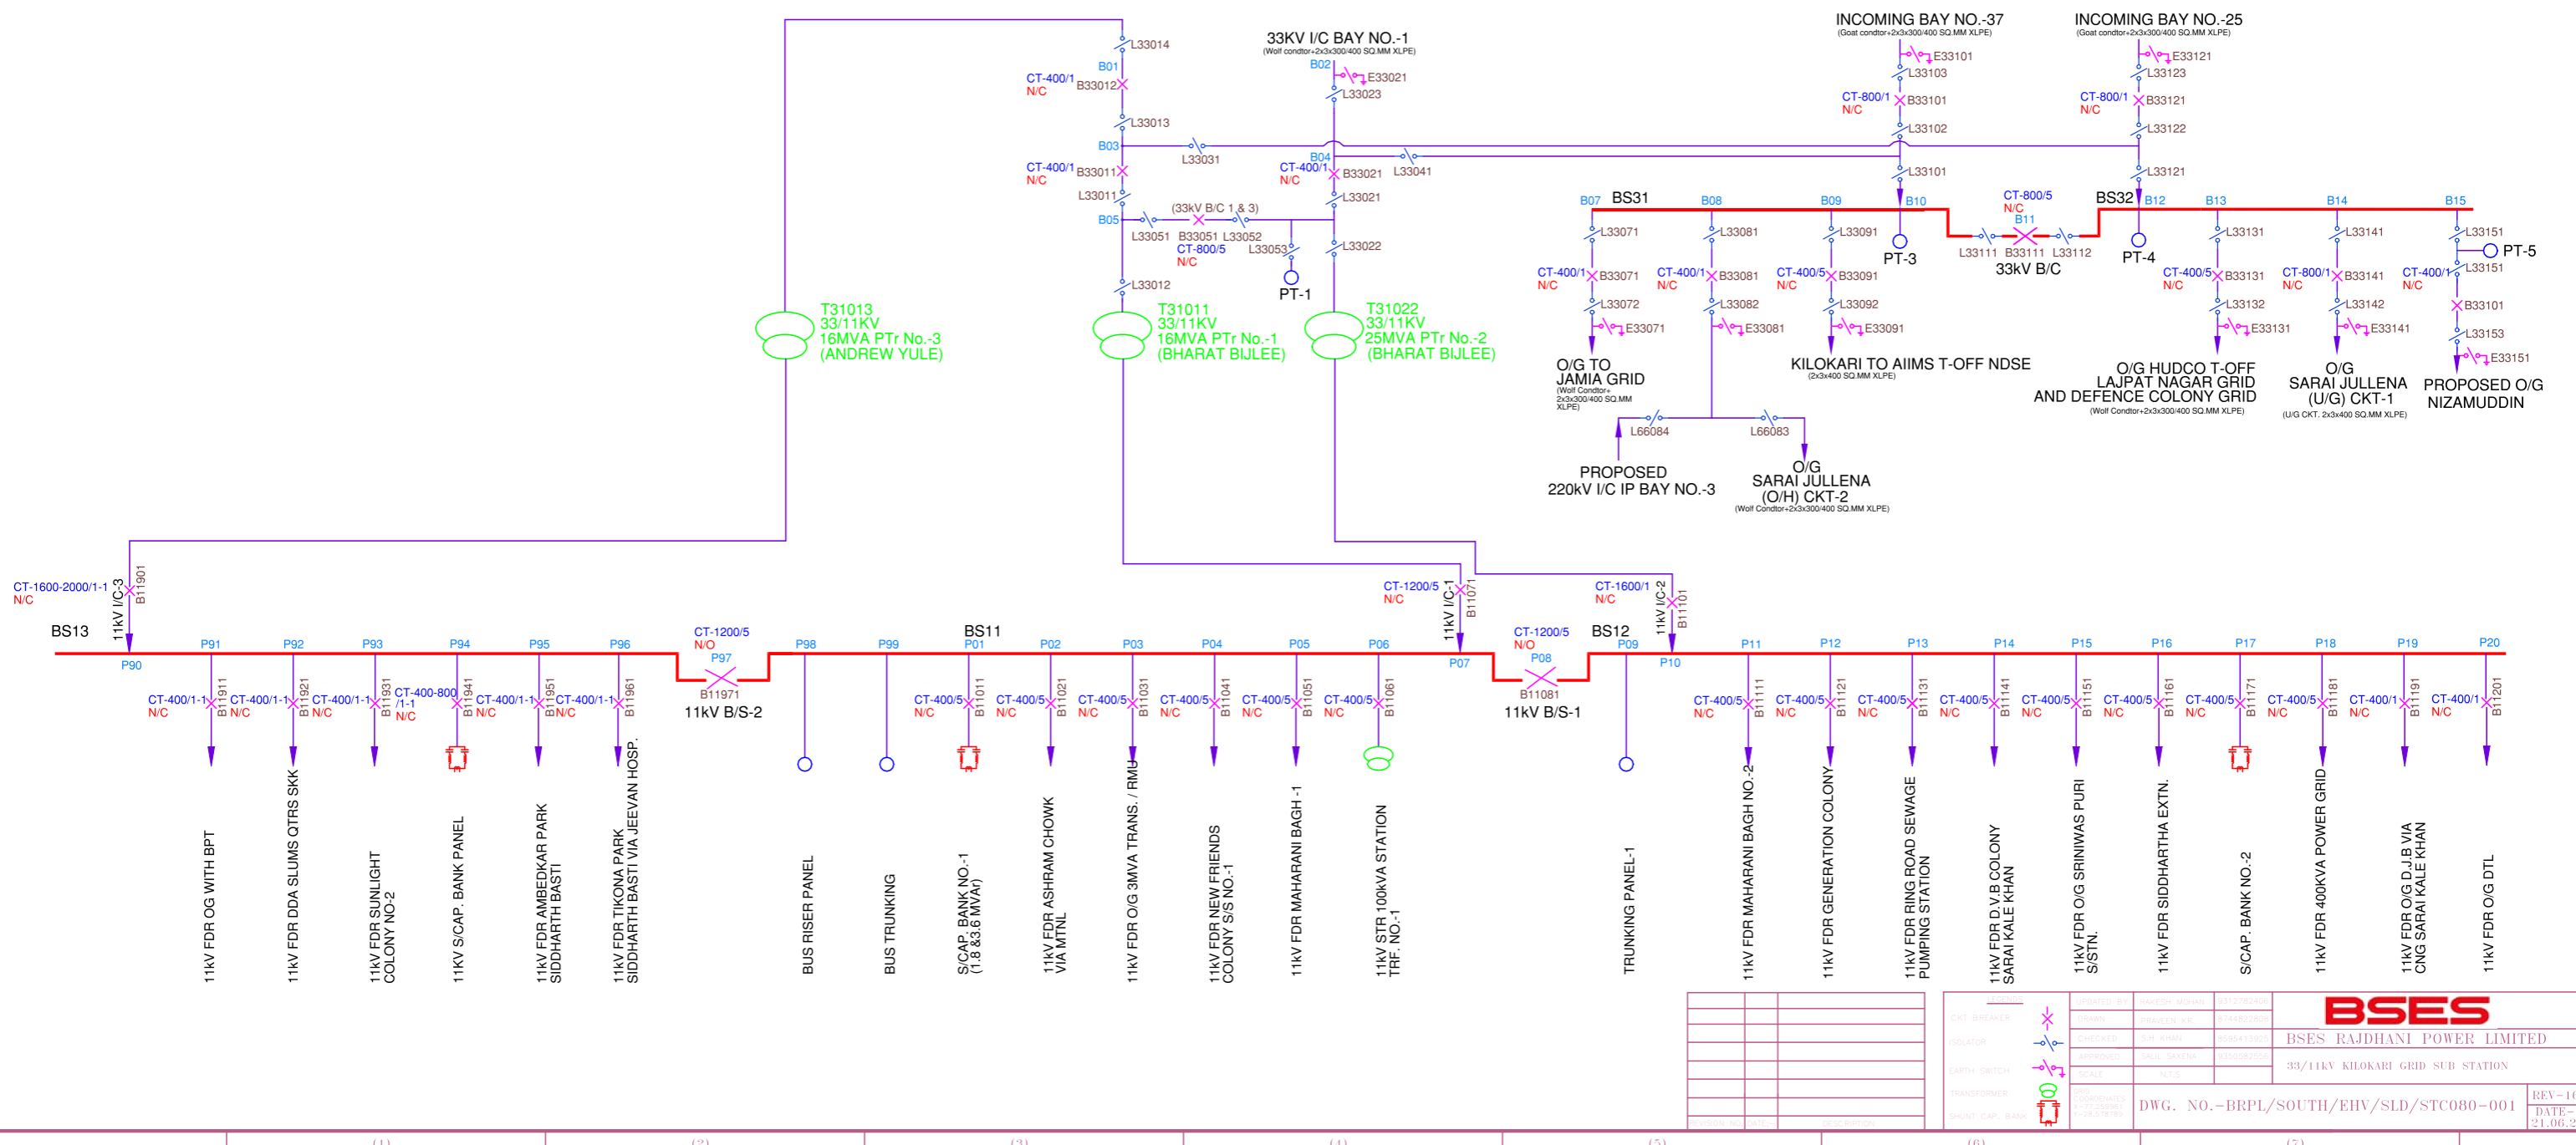

NO.	DESCRIPTION

<p>  Ckt. Breaker   Isolator   Earth Switch   Transformer   Shunt Cap. Bank                 </p>	<p>                     UPDATED BY: ANKESH MOHAN / 0512150406                      DRAWN: / 07448212035                      CHECKED: S.H. KHAN / 0600413905                      APPROVED: ANIL SAKSENA / 0303082030                      TITLE: 33/11KV                      PROJECT NO. / 2-11-200801 / 2-11-15303                 </p>
--	--

**BSES**

**BSES RAJDHANI POWER LIMITED**

33/11KV KILOKARI GRID SUB STATION

DWG. NO.-BRPL/SOUTH/EHV/SLD/STC080-001	REV-16
DATE-21.06.22	